



**EXISTING DANIELS BOOSTER PUMP STATION DATA**

ADDRESS: 7401 NORTH LAKE RD.  
 OPERATION CONDITION:  
 65 GPM @ 48' TDH  
 XXXXNEW FFE OF STATION: 7.50FT MSL

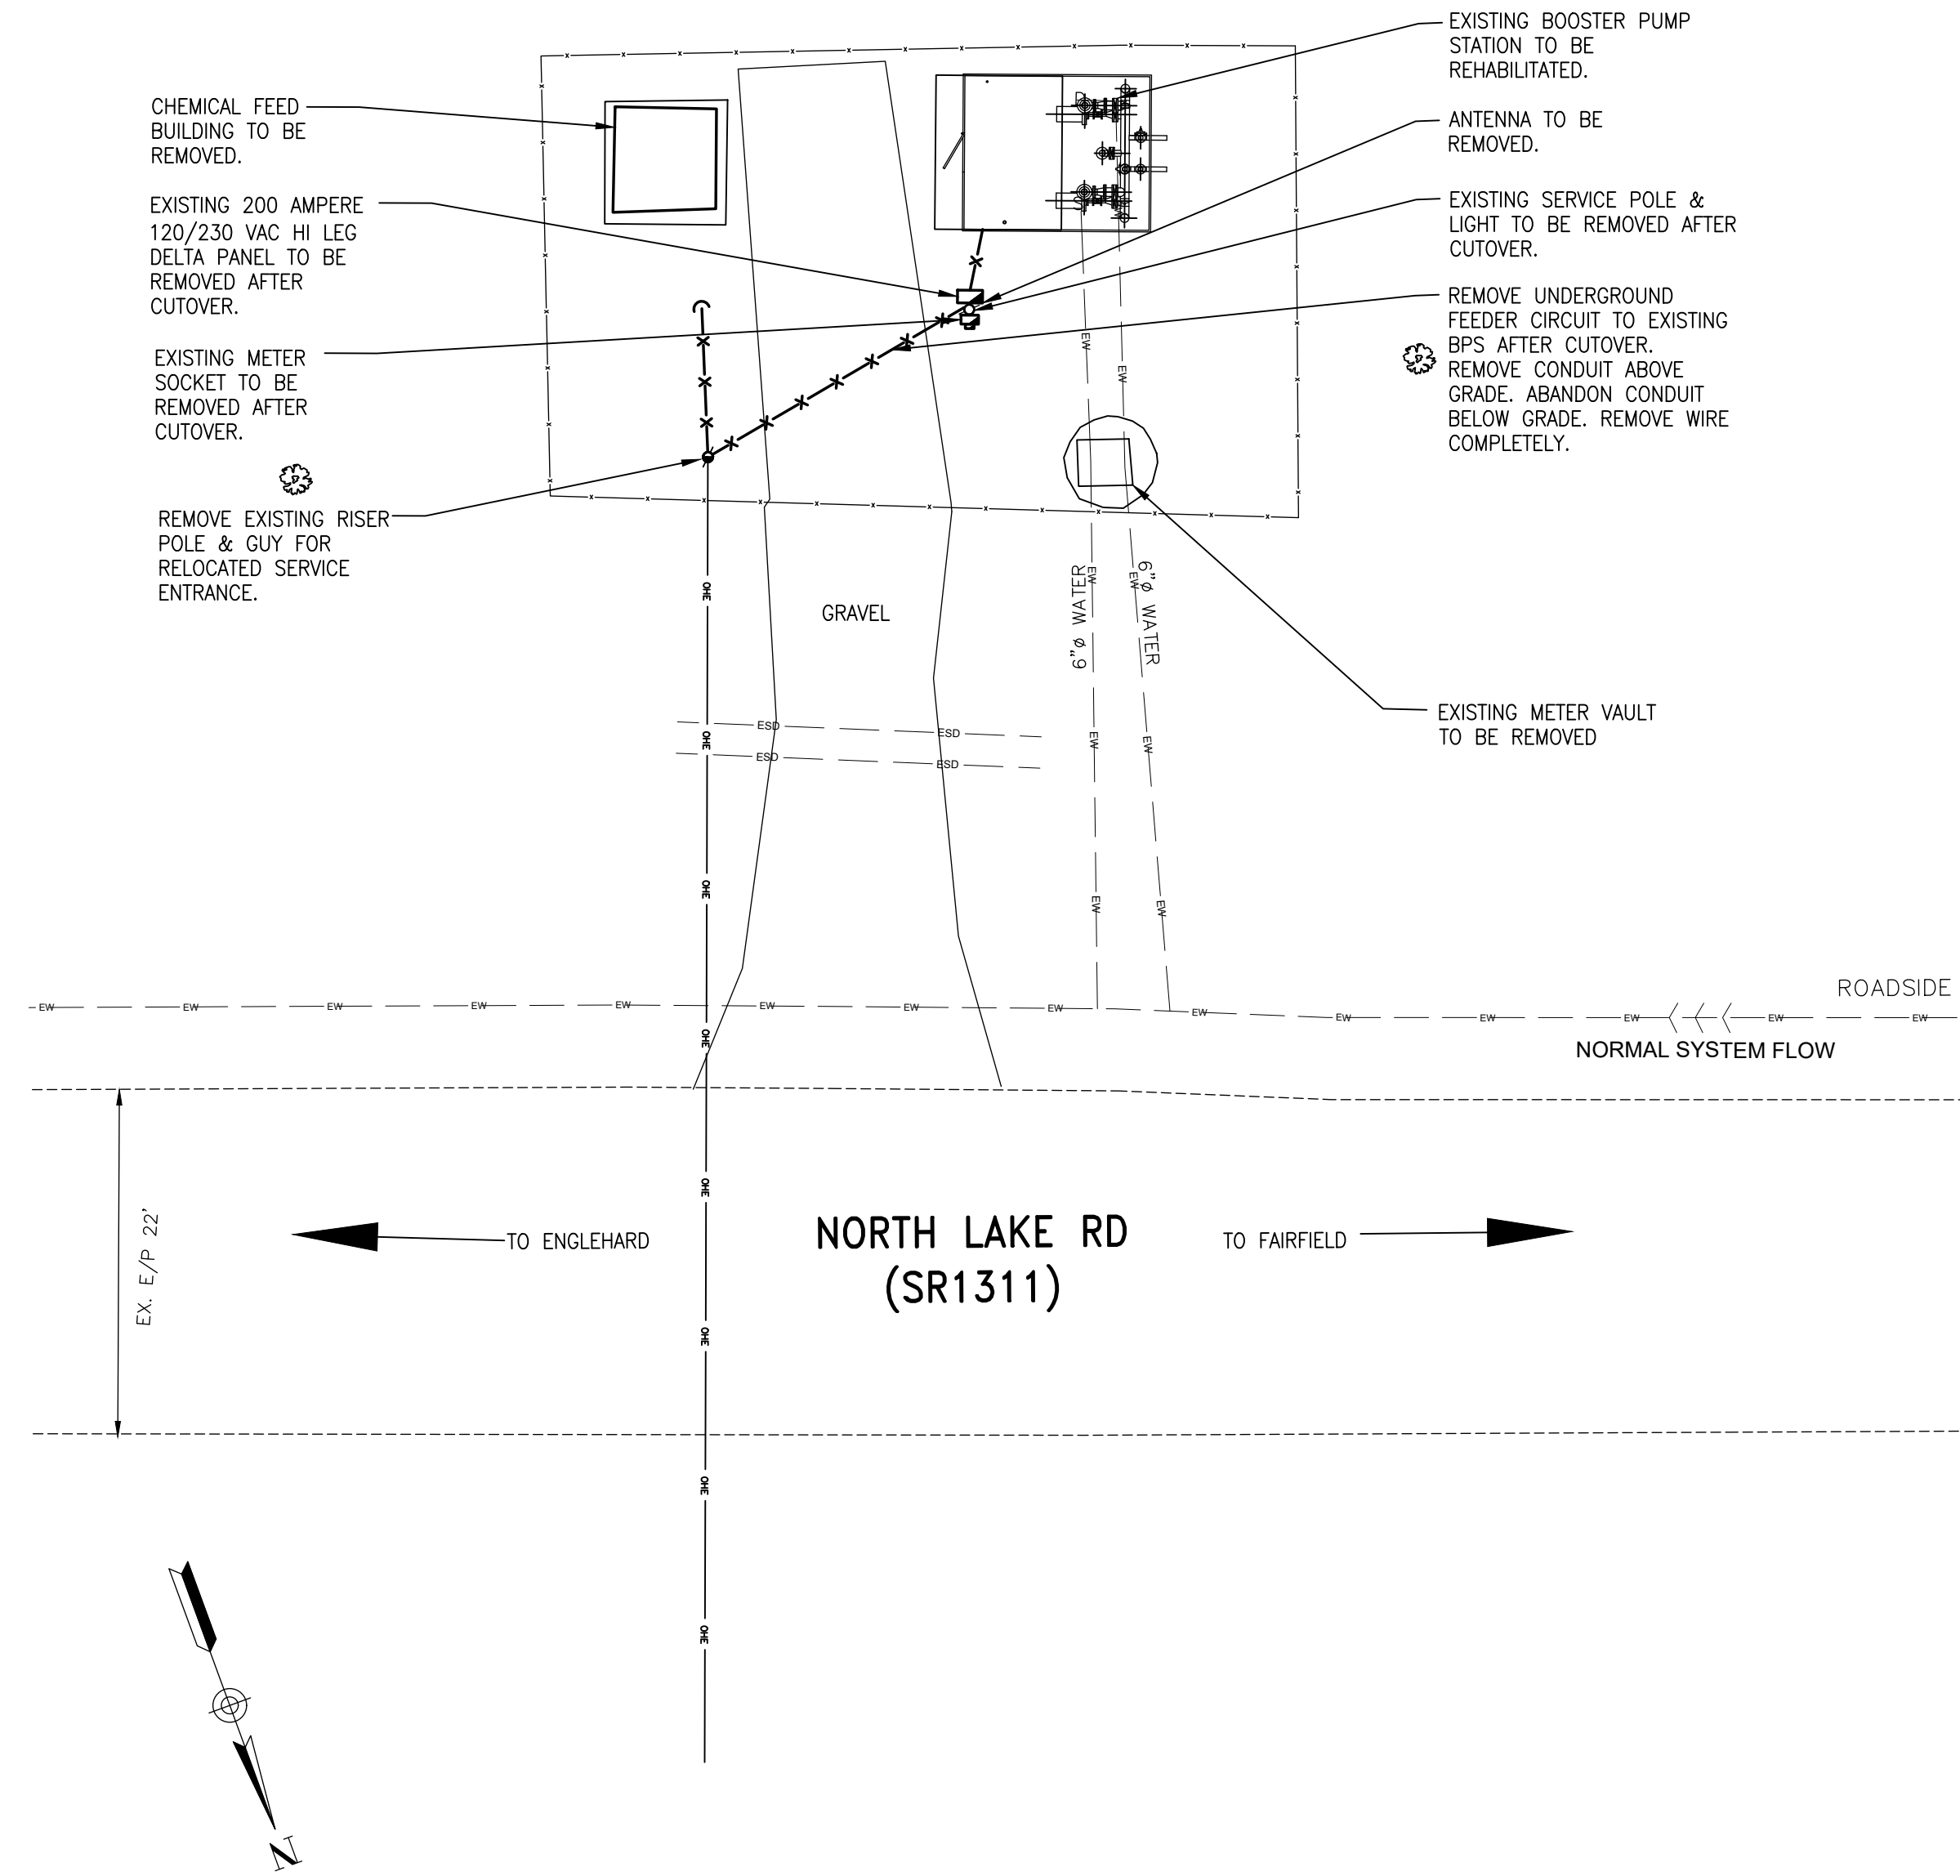

**1 DANIELS ELECTRICAL SITE PLAN**  
**E-7 DEMOLITION** 1"=10'-0"

**BOOSTER STATION DEMOLITION NOTES:**  
 REMOVE EXISTING PUMPS, CONTROLS, PIPING, & VALVES. REHABILITATE EXISTING PUMP STATION BUILDING WITH NEW PUMPS, CONTROLS, PIPING, & VALVES.

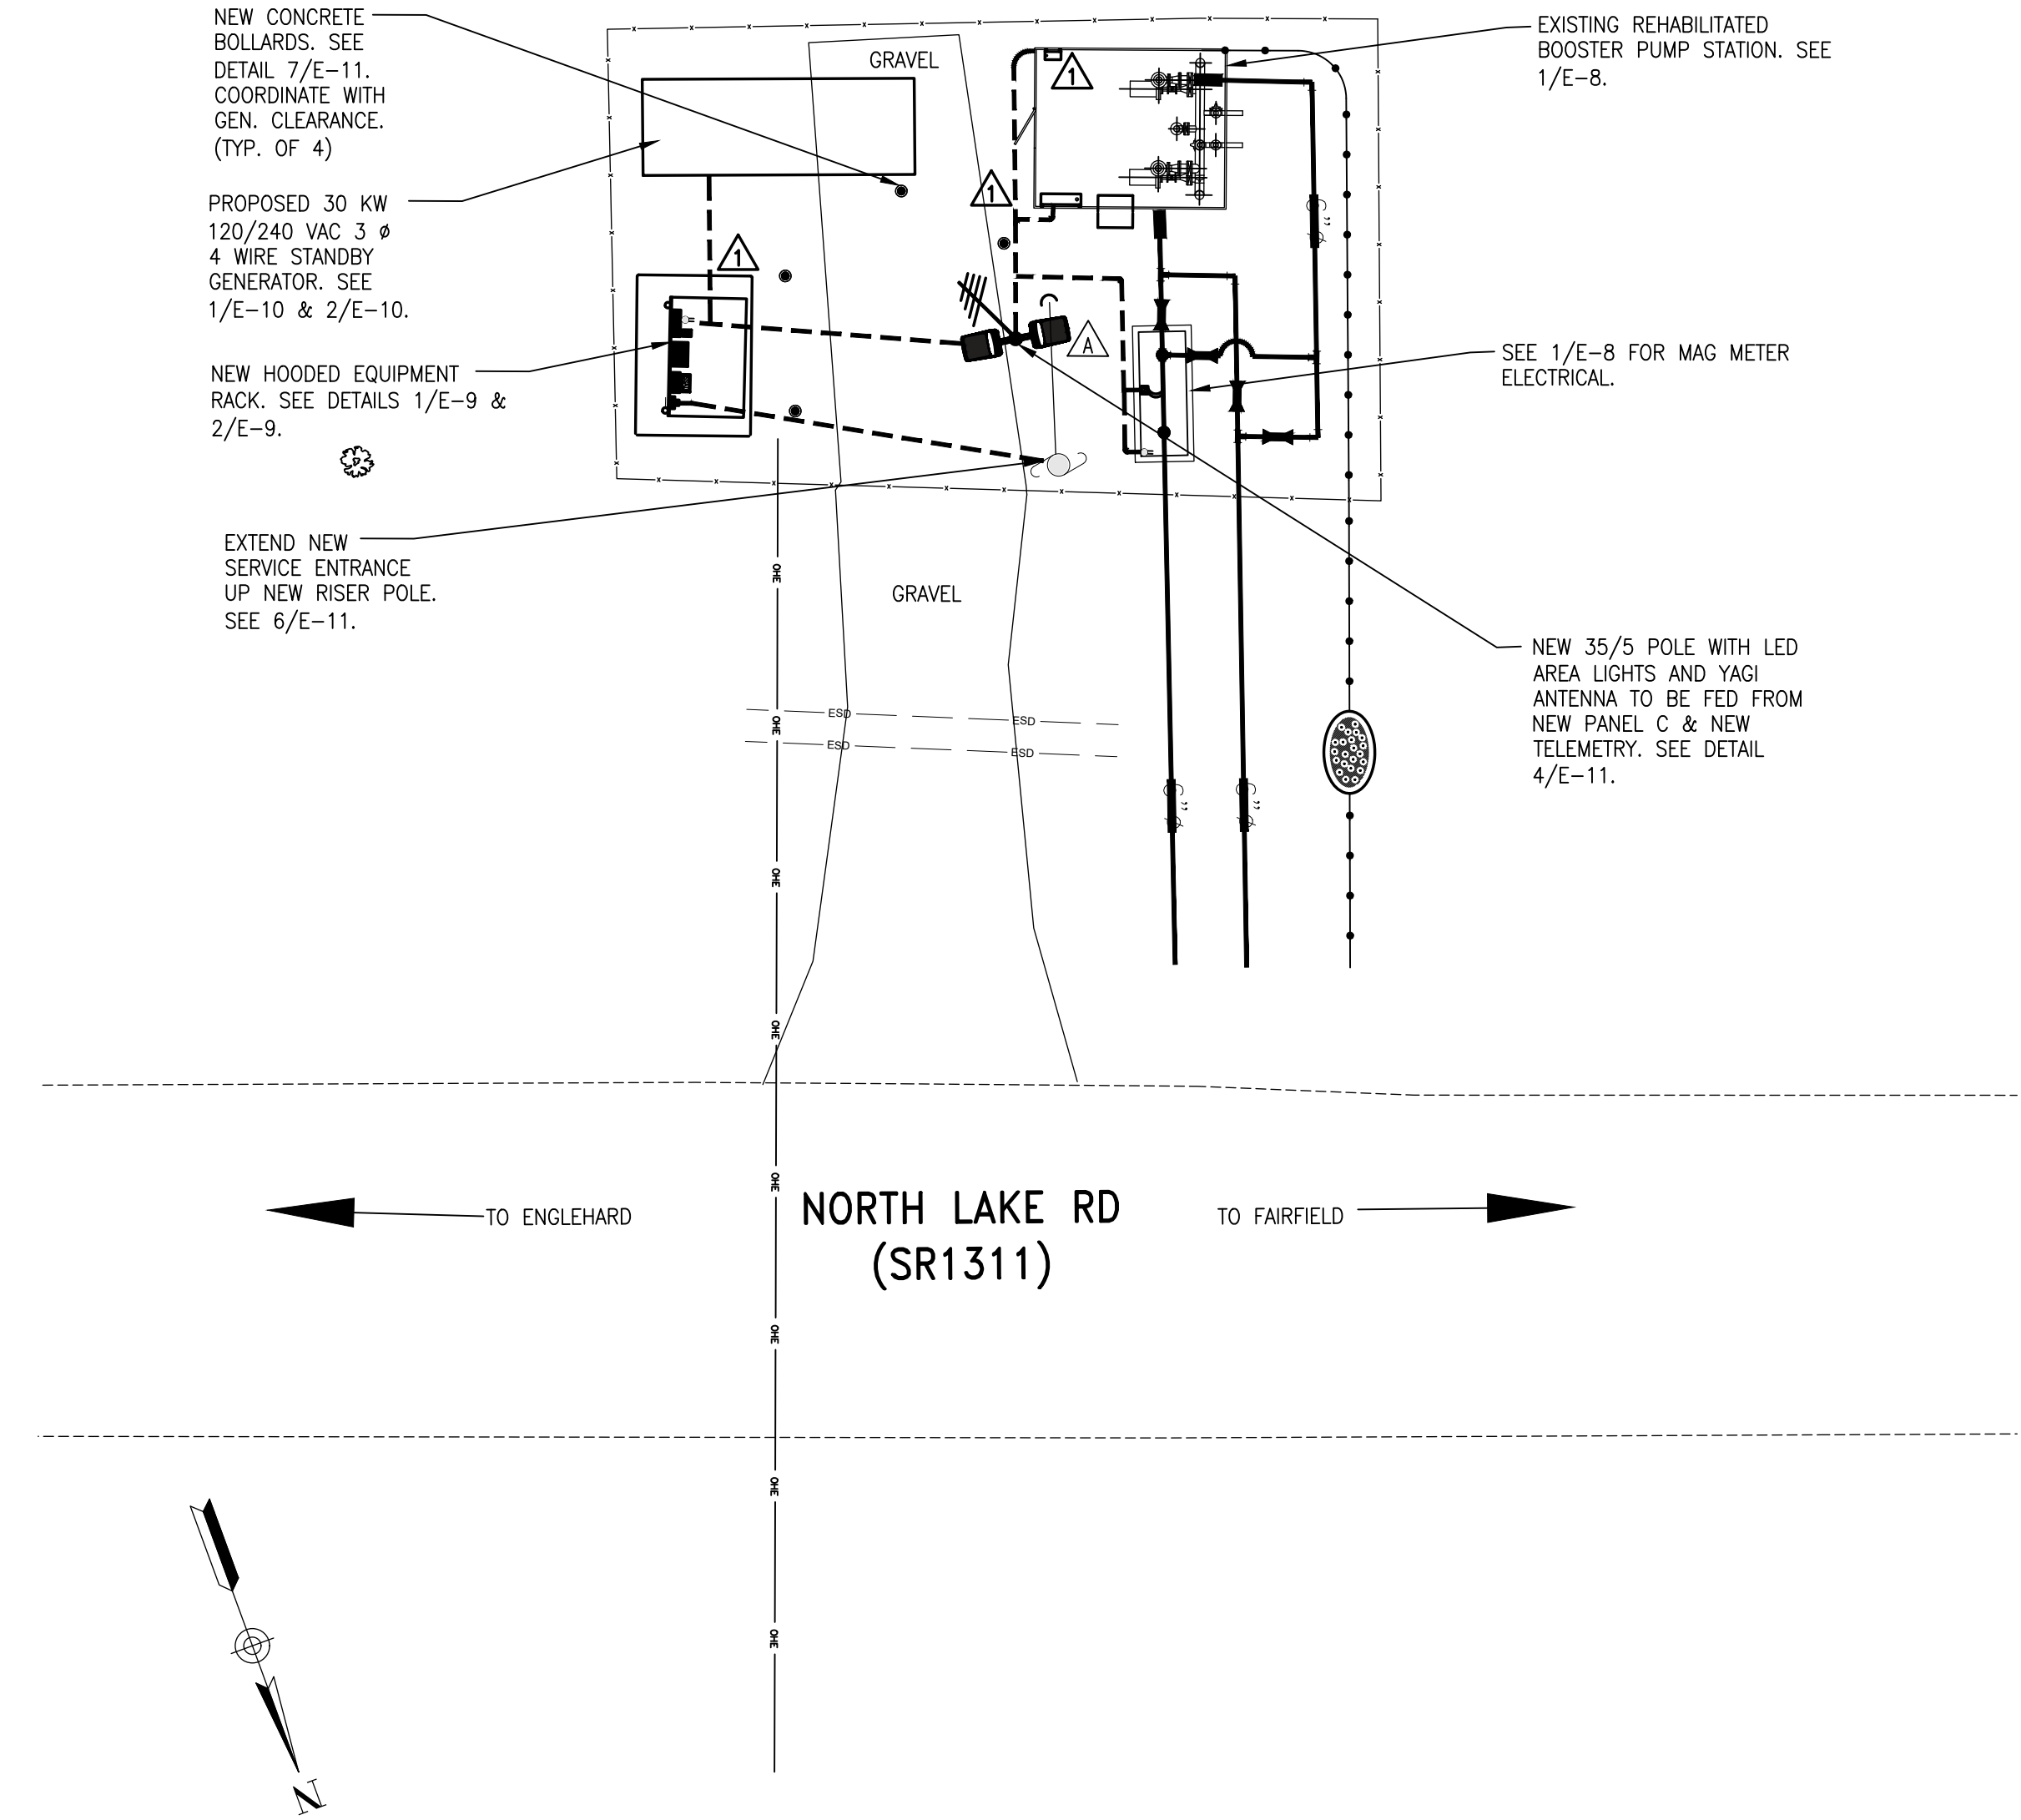

**2 DANIELS ELECTRICAL SITE PLAN**  
**E-7 INSTALLATION** 1"=10'-0"

*Ronald E. Pledger*  
 NORTH CAROLINA PROFESSIONAL ENGINEER  
 SEAL C-0416  
 SEAL 11654  
 ROYAL D. PLEDGER, P.A.  
 #1676 LD6341

11/6/2025

**DP** ELECTRICAL DESIGN BY:  
**DIBBLE & PLEDGER, P.A.**  
 222 WEST MAIN STREET, WASHINGTON N.C. 27889  
 PHONE: (252) 946-3320 FAX: (252) 946-5160  
 E-MAIL: rpledger@dibbleandpledger.com

RELEASED FOR CONSTRUCTION

| REVISION         | DATE    | BY  | DATE             |
|------------------|---------|-----|------------------|
| ADDENDA #1 SCADA | 3/19/25 | REP | October 30, 2023 |
|                  |         |     |                  |
|                  |         |     |                  |
|                  |         |     |                  |

GRAPHIC SCALE  
 0 10 20  
 SCALE IN FEET

CLIENT CODE: XXXXX  
 JOB NUMBER: XX-XXX  
 FIELD BOOK: XXX  
 CADFILE: LD6341.dwg  
 ASCII FILE:  
 LAST MODIFIED: 30-Oct-23  
 MODIFIED BY: XXX

SHEET No. **E-7** OF **11**

**GREEN ENGINEERING**  
 WATER, WASTEWATER, SURVEYING, PLANNING, PROJECT MANAGEMENT  
 NORTH CAROLINA FIRM LICENSE: P-0115  
 303 GOLDSBORO STREET EAST, P.O. BOX 609 WILSON, N.C. 27893  
 TEL (252) 237-5365 FAX (252) 243-7489 OFFICE@GREENENG.COM

**HYDE COUNTY PUBLIC UTILITIES**  
**BOOSTER PUMP STATIONS**  
 TOWN / CITY NAME COUNTY, NORTH CAROLINA

**DANIELS ELECTRICAL**  
**DEMOLITION +**  
**INSTALLATION SITE**  
**PLANS**